



Republic of the Philippines
BULACAN STATE UNIVERSITY
City of Malolos

BIDS AND AWARDS COMMITTEE FOR GOODS, SUPPLIES, AND SERVICES

October 5, 2021

Bid Bulletin No. 1 Modification in the Invitation to Bid, Schedule of Requirements and Technical Specification

This Bid Bulletin no. 1 is issued to modify or amend items in the Bidding Documents for project “**Supply, Delivery, and Installation of Sound System for E-Library Building**” with reference no. **G-2021-33**. This shall form an integral part of the said Bidding Documents.

I. Invitation to Bid

No.	FROM	TO
2	The <i>Bulacan State University (BuSU)</i> now invites bids for <i>Supply, Delivery, and Installation of Sound System for E-Library Building (G-2021-33)</i> . Delivery of the Goods is required within <i>Ninety (90) calendar days upon receipt of Notice to Proceed and Purchase Order</i> . Bidders should have completed, <i>within the last three (3) years</i> from the date of submission and receipt of bids (October 19, 2021), a contract similar to the Project. The description of an eligible bidder is contained in the Bidding Documents, particularly, in Section II. Instructions to Bidders.	The <i>Bulacan State University (BuSU)</i> now invites bids for <i>Supply, Delivery, and Installation of Sound System for E-Library Building (G-2021-33)</i> . Delivery of the Goods is required within <i>One Hundred Twenty (120) calendar days upon receipt of Notice to Proceed and Purchase Order</i> . Bidders should have completed, <i>within the last three (3) years</i> from the date of submission and receipt of bids (October 19, 2021), a contract similar to the Project. The description of an eligible bidder is contained in the Bidding Documents, particularly, in Section II. Instructions to Bidders.

II. Section VI. Schedule of Requirements

	FROM	TO
Delivered, Weeks/Months	Ninety (90) Calendar Days upon receipt of Notice to Proceed.	<u>One Hundred Twenty (120) Calendar Days upon receipt of Notice to Proceed.</u>

III. Section VII. Technical Specifications

Please see attached “Plan/Layout”


This Supplemental/ Bid Bulletin no. 1 is issued this 5th day of October, 2021 for guidance and information of all concerned.


Dr. DOLLY P. MAROMA
Chairperson, BAC for Goods, Supplies & Services


Received by the Bidder:

Signature over printed name/ Company


Date and time: _____

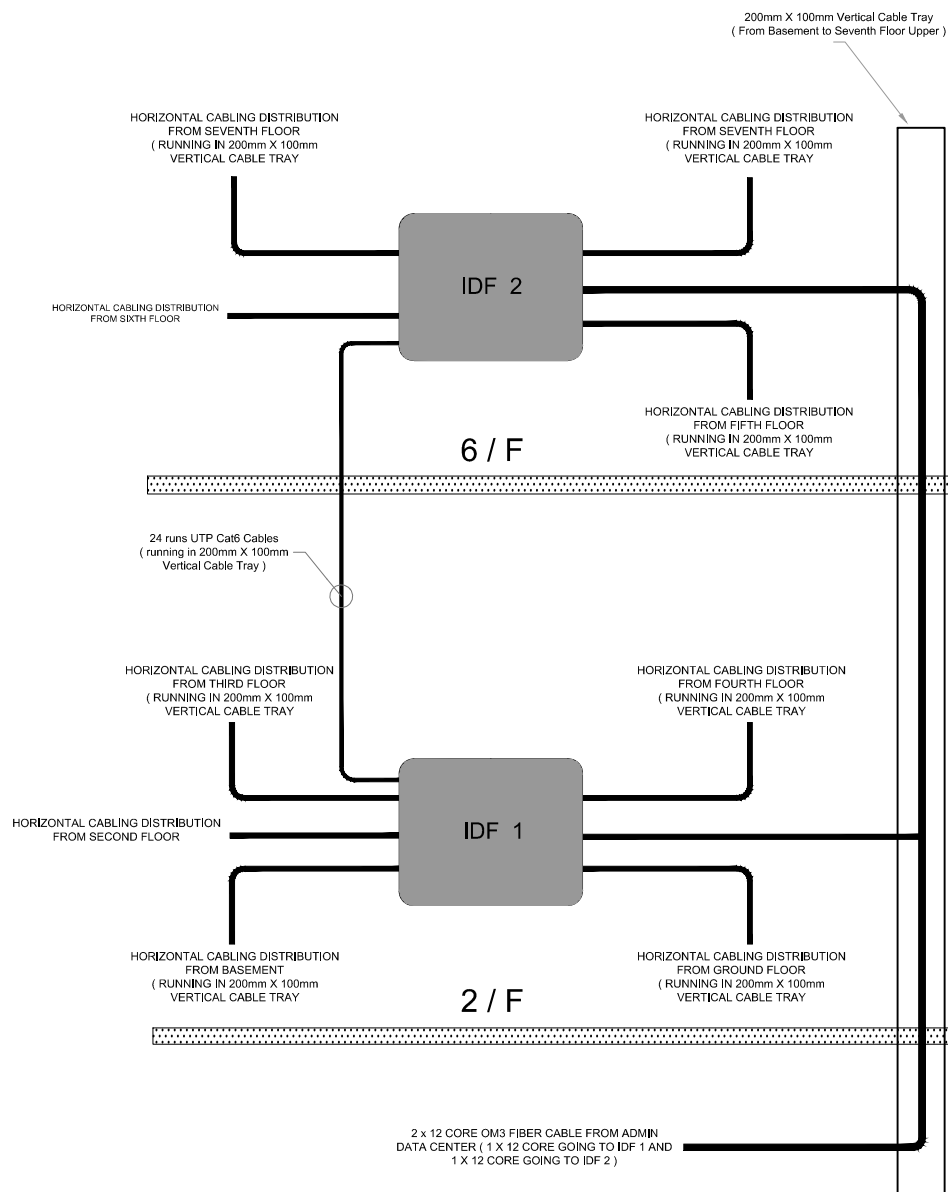


SINGLE LINE DIAGRAM

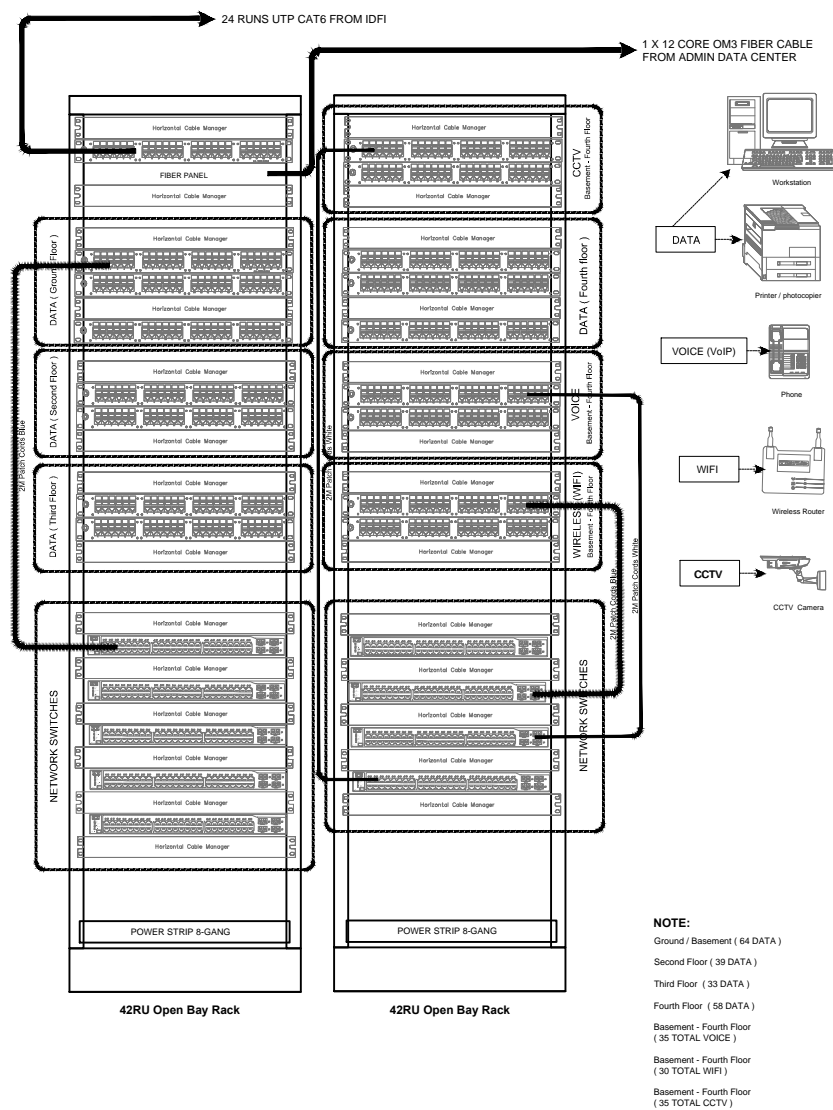


RACK LAYOUT IDF 1

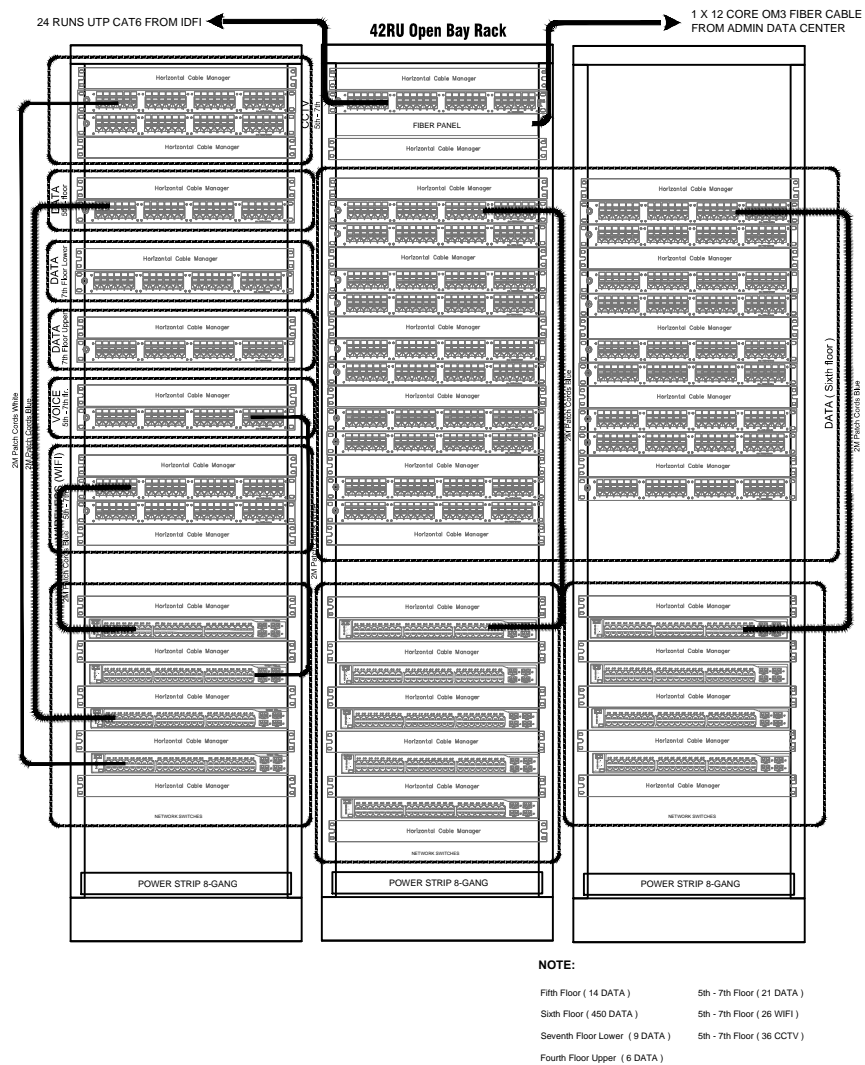

RACK LAYOUT IDF 2

<div><div>BULACAN STATE UNIVERSITY PROJECT MANAGEMENT OFFICE BRGY. GUINHAWA, CITY OF MALOLOS, BULACAN Tel. No.: (044) 919-7800 E-mail address: bulsu.pmo2013@gmail.com</div></div>	PROJECT TITLE:		PREPARED BY:		SUBMITTED BY:		RECOMMENDING APPROVAL:		RECOMMENDING APPROVAL:		APPROVAL:		SHEET CONTENTS:		SHEET NO.:	
	DATA NETWORK - STRUCTURED CABLING AND COMPONENTS AND SOUND SYSTEM OF E-LIBRARY BUILDING		OLIVER R. MARIANO, ASEAN Eng DESIGNER		AR. MA. SATURNINA C. PARUNGAO, Iup DEPUTY DIRECTOR, PROJECT MANAGEMENT OFFICE		ENGR. IVY MAR J. RAMOS EXECUTIVE DIRECTOR, STRATEGIC MANAGEMENT AND DEVELOPMENT		TEODY C. SAN ANDRES, Ph.D EXECUTIVE VICE PRESIDENT		CECILIA N. GASCON, Ph.D UNIVERSITY PRESIDENT		SINGLE LINE DIAGRAM RACK LAYOUT IDF 1 RACK LAYOUT IDF 2		AUX-2 07	
			REG. NO.: 0000109	PTR NO.: 6350075	CAD BY:	CHECK BY:										
			TIN NO.: 185-452-561	ISSUED ON: 01/05/2021	HJC	O R M										
			ISSUED AT: BULACAN	DATE:	DATE:											
LOCATION: BULSU MALOLOS.																

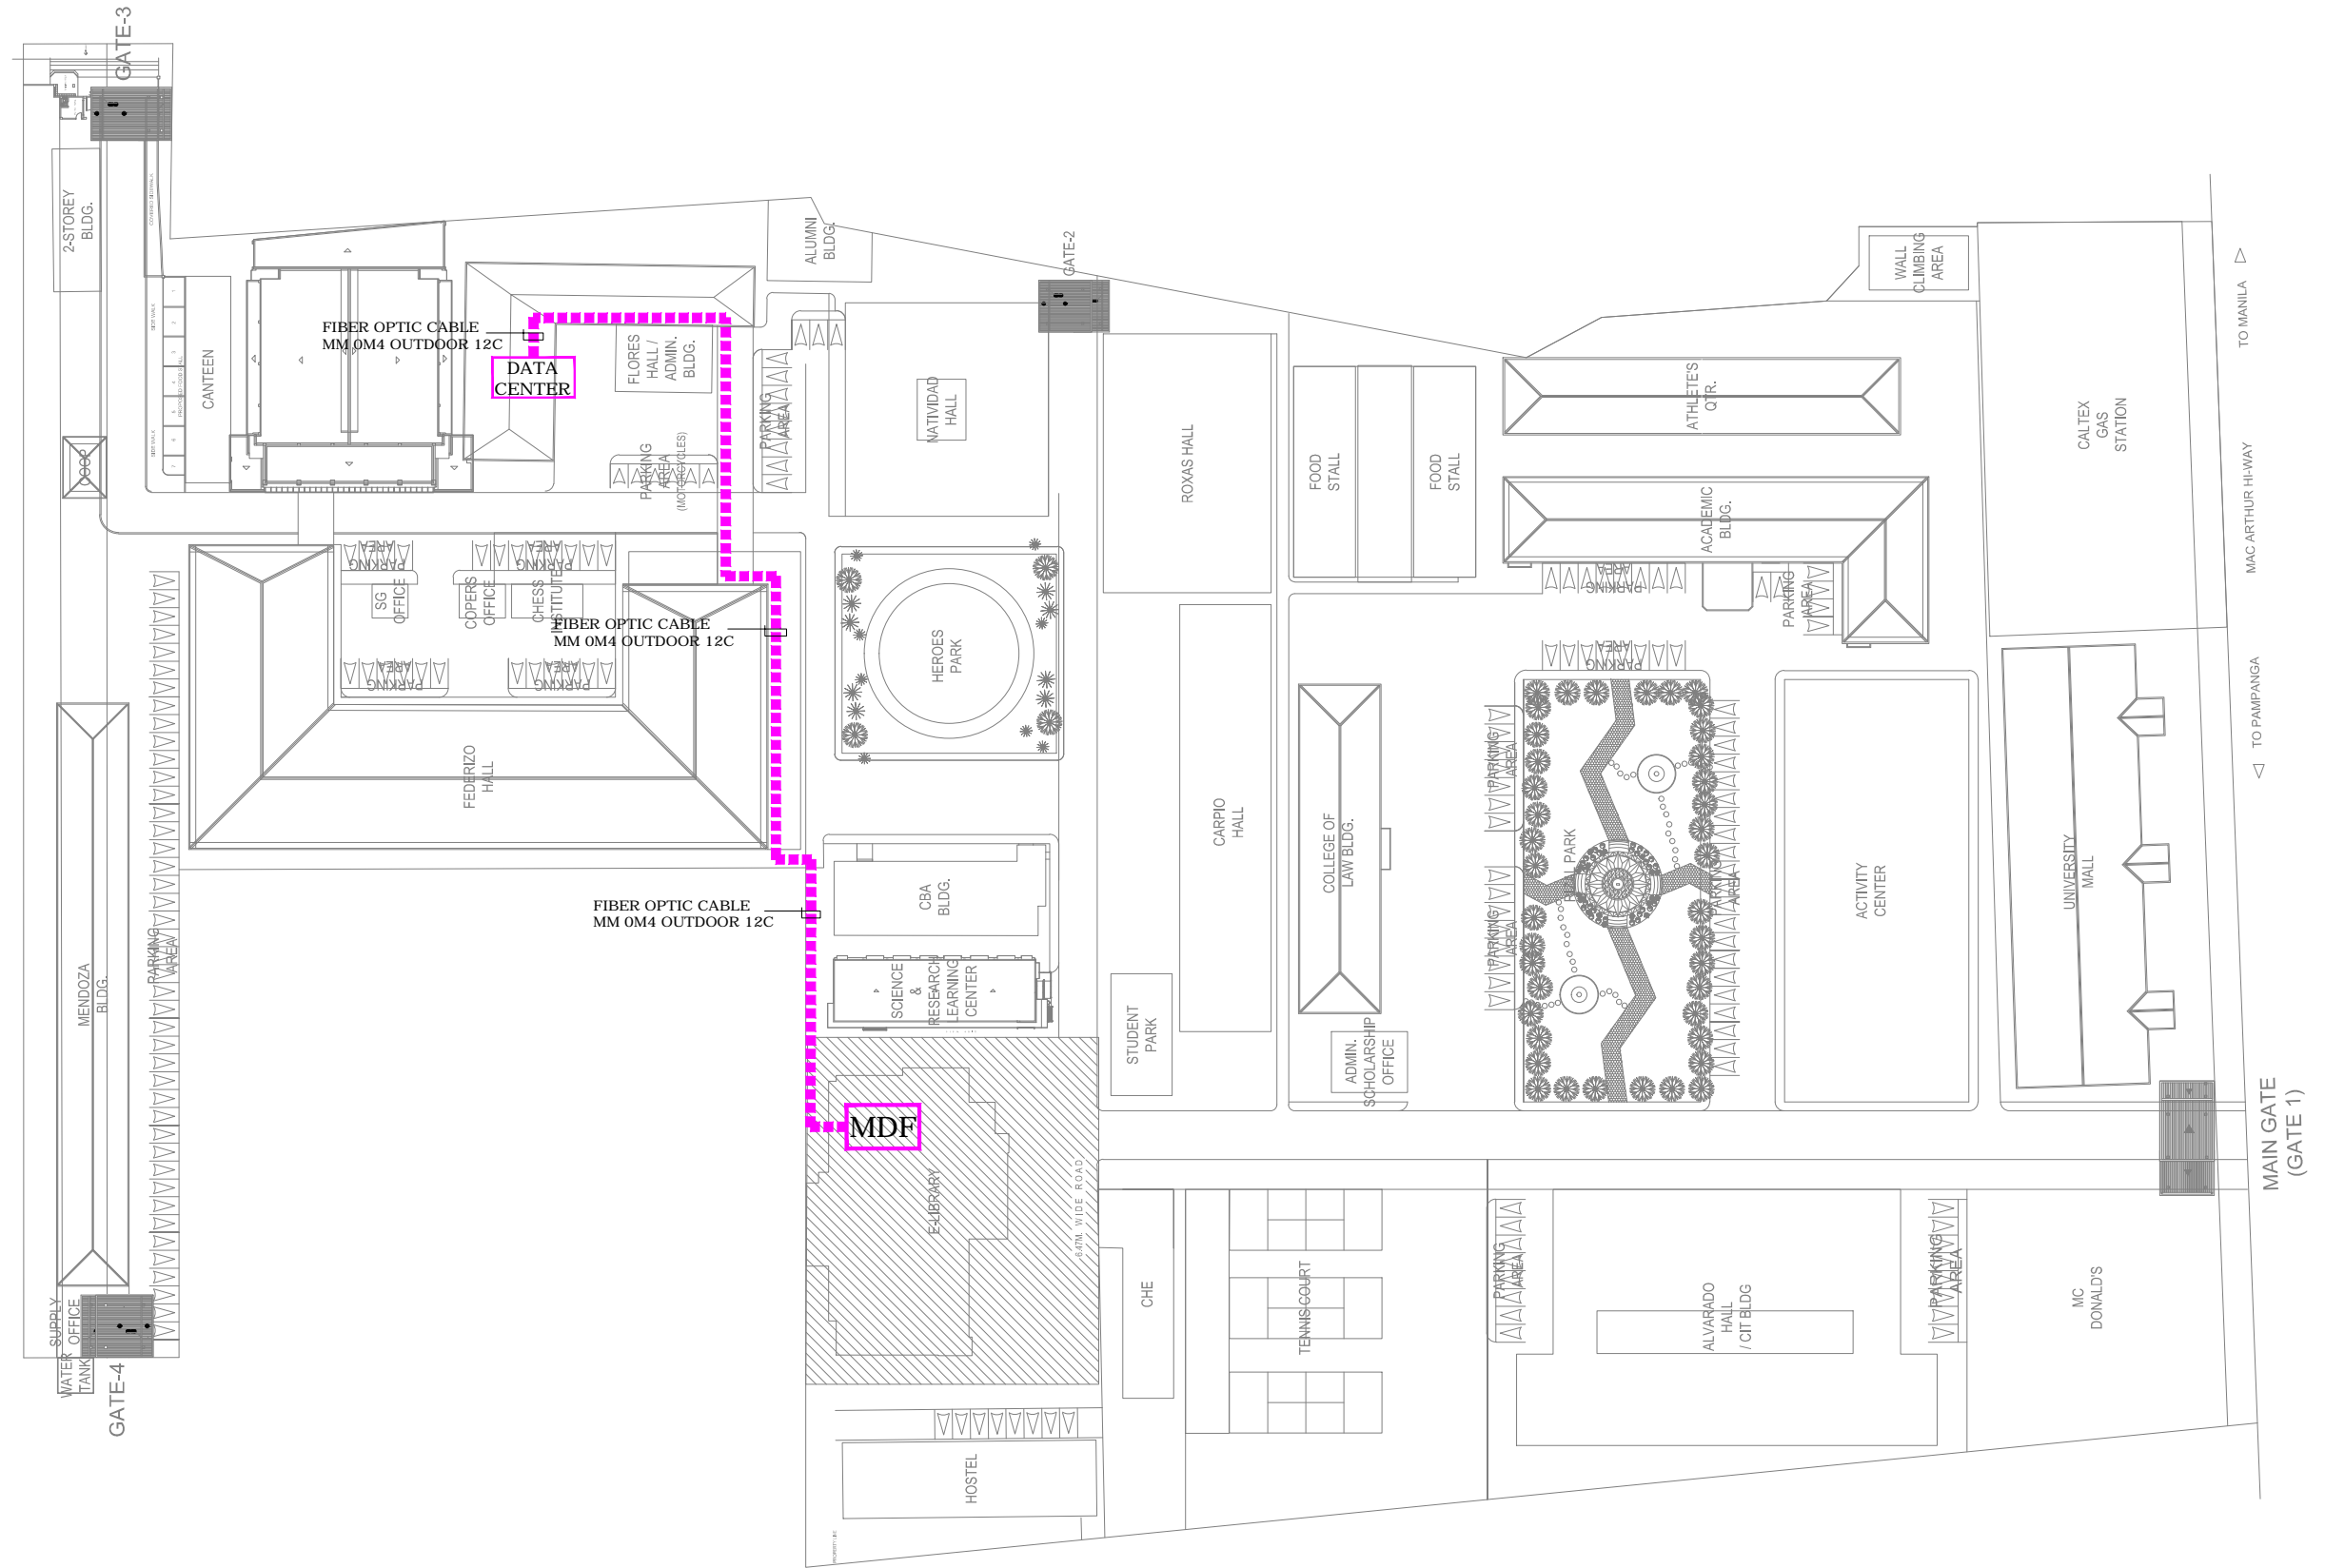

STRUCTURED CABLING LAYOUT

SCALE:

NTS



BULACAN STATE UNIVERSITY
PROJECT MANAGEMENT OFFICE
BRGY. GUINHAWA, CITY OF MALOLOS, BULACAN
Tel. No.: (044) 919-7800
E-mail address: bulsu.pmo2013@gmail.com

PROJECT TITLE:

DATA NETWORK - STRUCTURED
CABLING AND COMPONENTS
AND SOUND SYSTEM OF
E-LIBRARY BUILDING

LOCATION: BULSU MALOLOS.

PREPARED BY:

OLIVER R. MARIANO, ASEAN Eng
DESIGNER

REG. NO.: 0000109

PTR NO.: 6350075

TIN NO.: 185-452-561

ISSUED ON: 01/05/2021

ISSUED AT: BULACAN

SUBMITTED BY:

AR. MA. SATURNINA C. PARUNGAO, fuap
DEPUTY DIRECTOR, PROJECT MANAGEMENT OFFICE

CAD BY:

HJC

DATE:

CHECK BY:

O R M

DATE:

RECOMMENDING APPROVAL:

ENGR. IVY MAR J. RAMOS
EXECUTIVE DIRECTOR, STRATEGIC MANAGEMENT
AND DEVELOPMENT

RECOMMENDING APPROVAL:

TEODY C. SAN ANDRES, Ph.D
EXECUTIVE VICE PRESIDENT

APPROVAL:

CECILIA N. GASCON, Ph.D
UNIVERSITY PRESIDENT

SHEET CONTENTS:

STRUCTURED CABLING LAYOUT


SHEET NO:

AUX-2.1

07

LEGEND:

AUDIO	VIDEO	CONTROL/AV PATCH	AV RACK	ELECTRICAL
ANALOG MIXER	MOTORIZED SCREEN 120"	KEYPAD - VIDEO	AUDIO-VIDEO EQUIPMENT RACK	FLOOR - POP UP BOX
6.5" CEILING SPEAKER	3LCD PROJECTOR	TOUCH PAD - AUDIO		CEILING MOUNT
PODIUM W/ MIC	MOTORIZED LIFT			WALL MOUNT
WIRELESS MIC	LED SCREEN 55"	AUDIO-VIDEO PATCH PLATE		

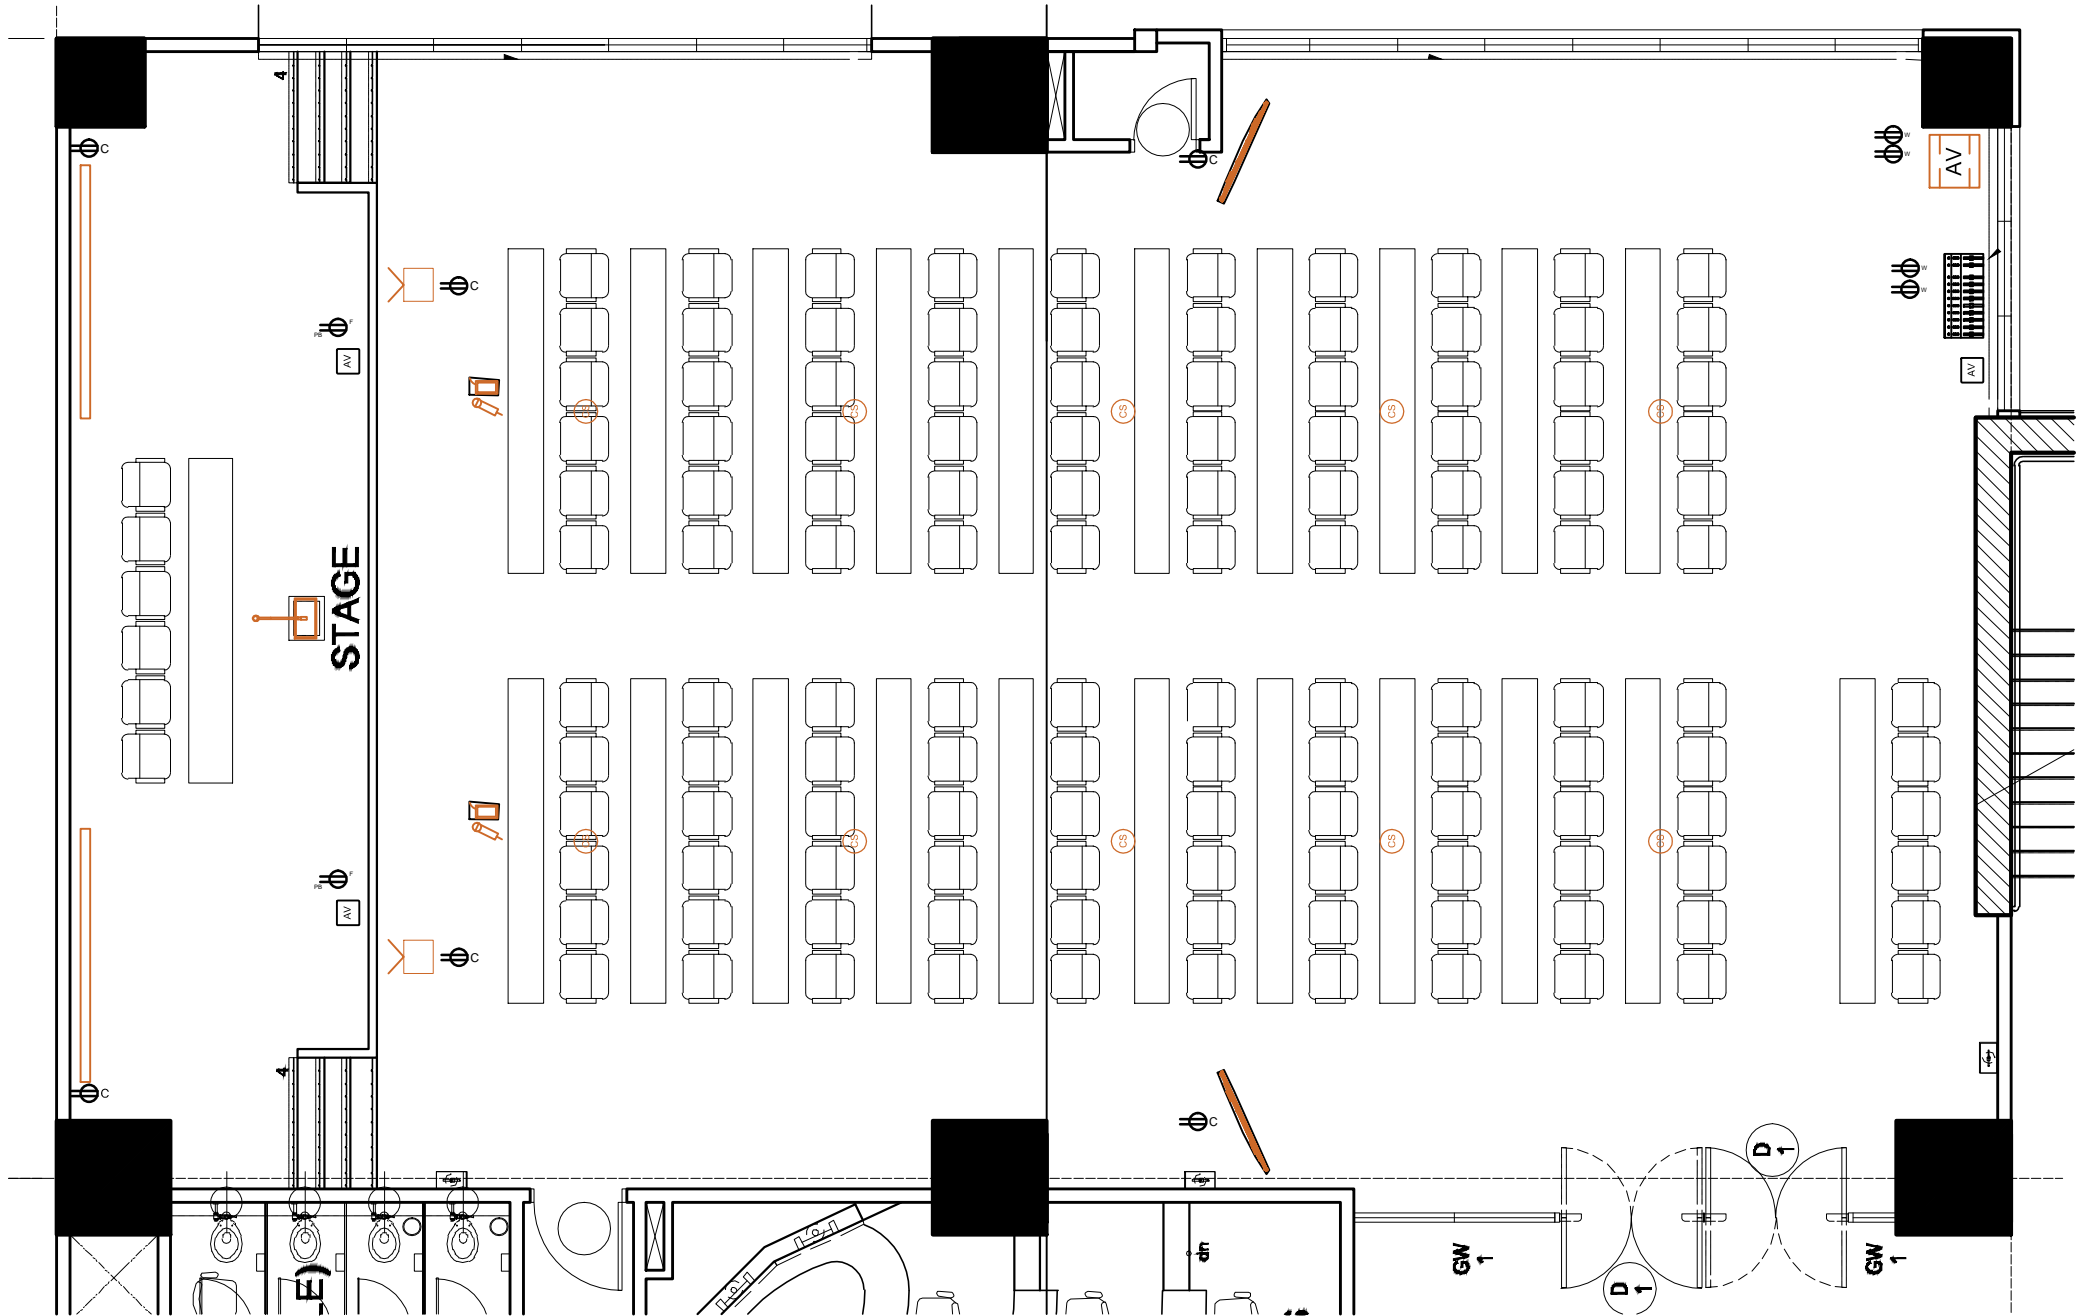

CONFERENCE HALL (5TH FLR.)
SOUND SYSTEM / SPECIAL LIGHTING & POWER LAYOUT
SCALE: NTS



BULACAN STATE UNIVERSITY
PROJECT MANAGEMENT OFFICE
BRGY. GUINHAWA, CITY OF MALOLOS, BULACAN
Tel. No.: (044) 919-7800
E-mail address: bulsu.pmo2013@gmail.com

PROJECT TITLE:
DATA NETWORK - STRUCTURED
CABLING AND COMPONENTS
AND SOUND SYSTEM OF
E-LIBRARY BUILDING
LOCATION: BULSU MALOLOS.

PREPARED BY:
OLIVER R. MARIANO, ASEAN Eng
DESIGNER
REG. NO.: 0000109 PTR NO.: 6350075
TIN NO.: 185-452-561 ISSUED ON: 01/05/2021
ISSUED AT: BULACAN

SUBMITTED BY:
AR. MA. SATURNINA C. PARUNGAO, fuap
DEPUTY DIRECTOR, PROJECT MANAGEMENT OFFICE
CAD BY: HJC CHECK BY: O R M
DATE: DATE:

RECOMMENDING APPROVAL:
ENGR. IVY MAR J. RAMOS
EXECUTIVE DIRECTOR, STRATEGIC MANAGEMENT
AND DEVELOPMENT

RECOMMENDING APPROVAL:
TEODY C. SAN ANDRES, Ph.D
EXECUTIVE VICE PRESIDENT


APPROVAL:
CECILIA N. GASCON, Ph.D
UNIVERSITY PRESIDENT

SHEET CONTENTS:
CONFERENCE HALL 5TH FLOOR


SHEET NO:
AUX-3
07

LEGEND:

AUDIO	VIDEO	CONTROL/AV PATCH	AV RACK	ELECTRICAL
6" WALL SPEAKER	MOTORIZED SCREEN 120"	KEYPAD - VIDEO	AUDIO-VIDEO EQUIPMENT RACK	FLOOR - POP UP BOX
SUBWOOFER	3LCD PROJECTOR	TOUCH PAD - AUDIO		CEILING MOUNT
PODIUM W/ MIC	MOTORIZED LIFT	AUDIO-VIDEO PATCH PLATE		WALL MOUNT
WIRELESS MIC	BYOD			

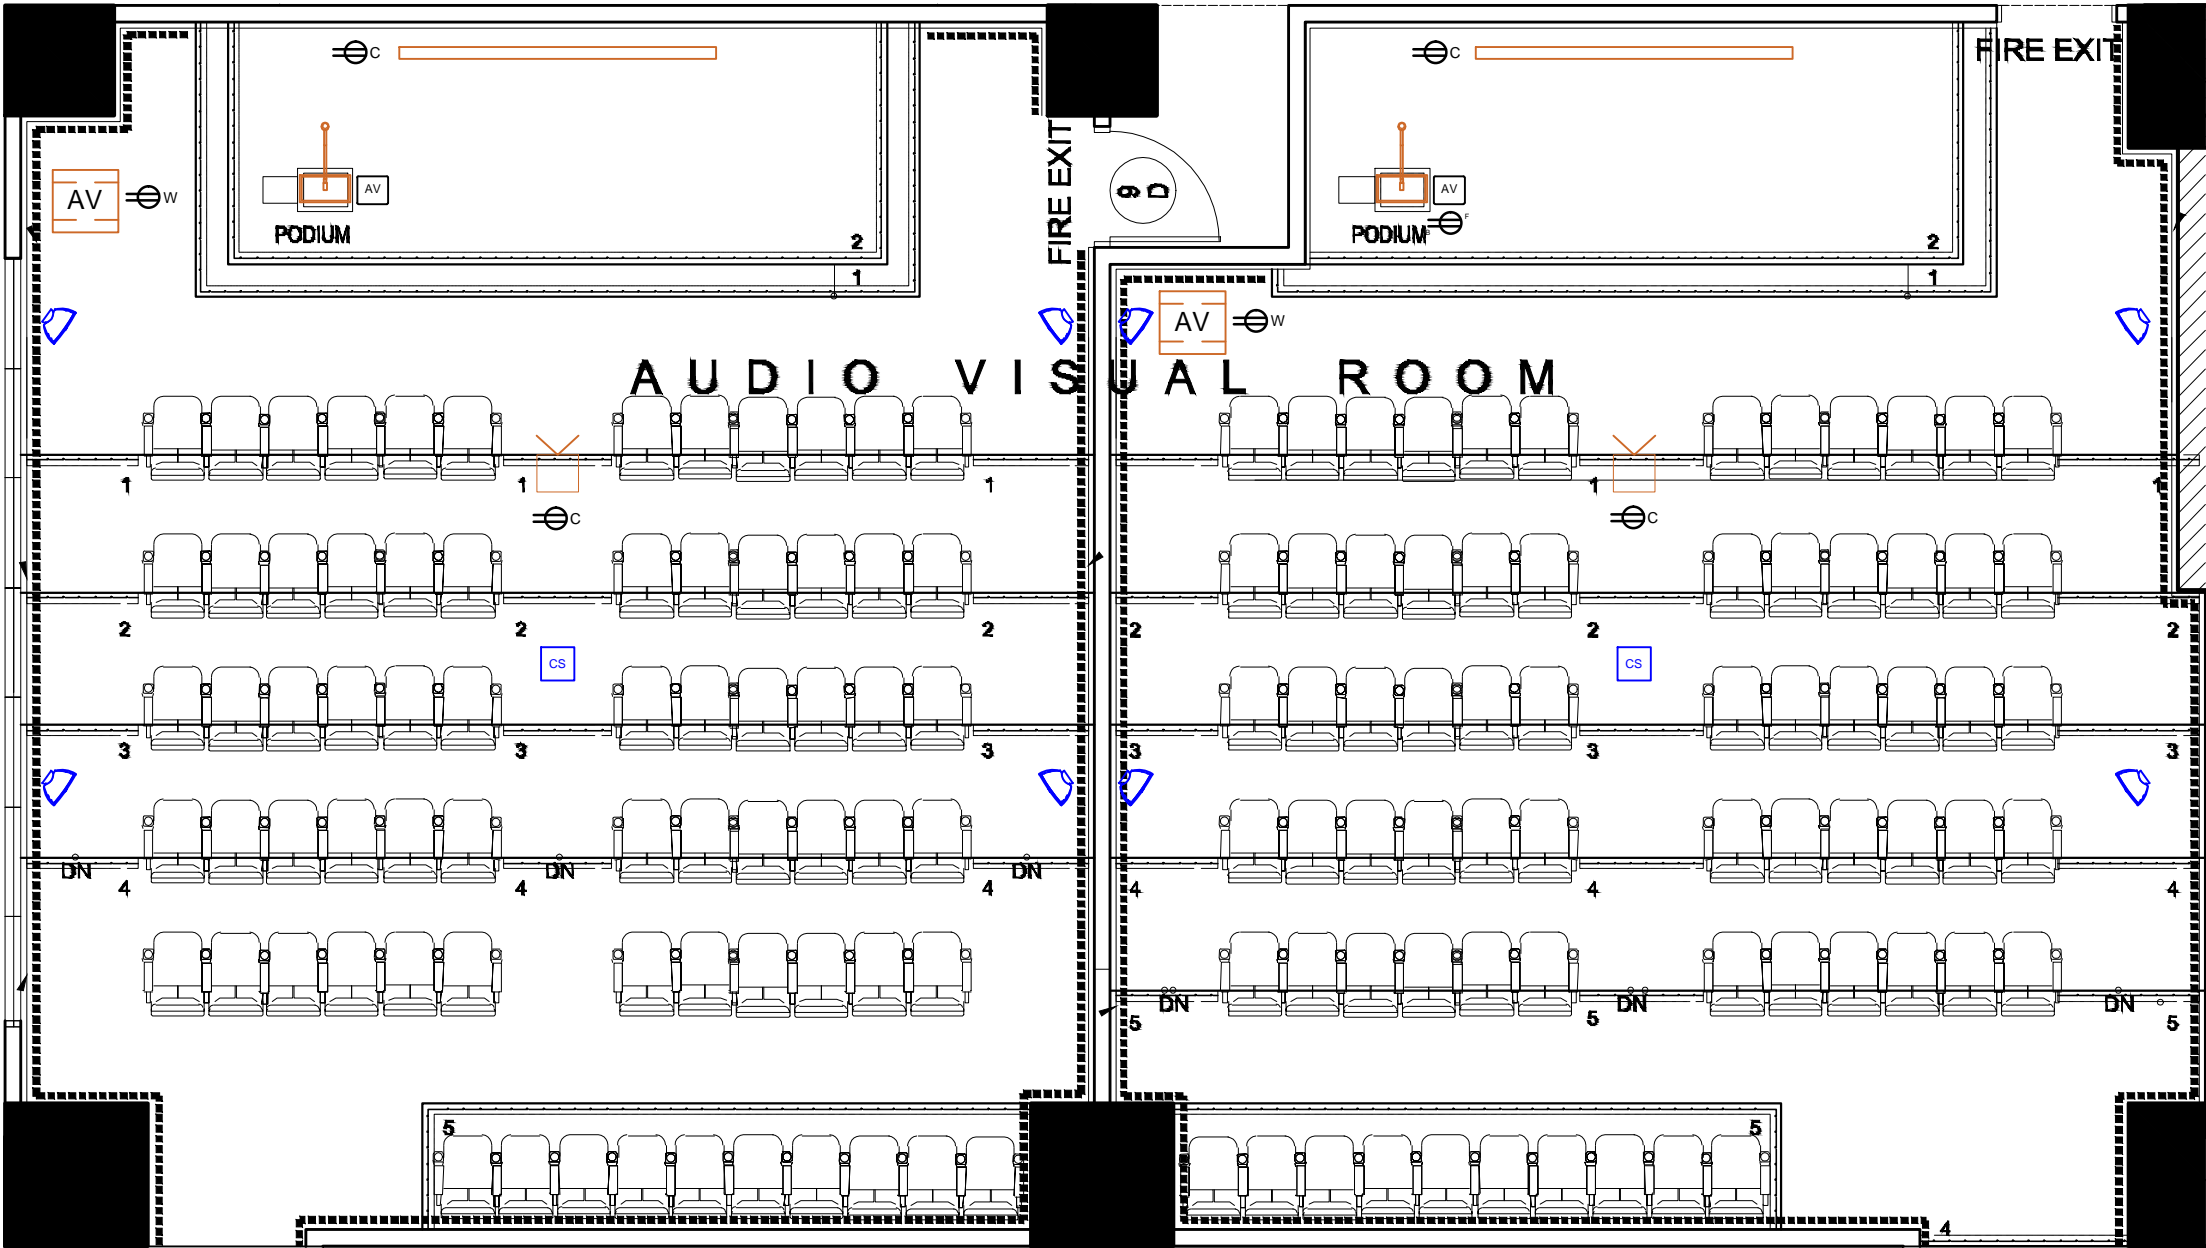

AVR 1 & 2 (5TH FLR.)

 

SOUND SYSTEM / SPECIAL LIGHTING & POWER LAYOUT

SCALE:

NTS



BULACAN STATE UNIVERSITY
PROJECT MANAGEMENT OFFICE
BRGY. GUINHAWA, CITY OF MALOLOS, BULACAN
Tel. No.: (044) 919-7800
E-mail address: bulsu.pmo2013@gmail.com

PROJECT TITLE:
DATA NETWORK - STRUCTURED
CABLING AND COMPONENTS
AND SOUND SYSTEM OF
E-LIBRARY BUILDING
LOCATION: BULSU MALOLOS.

PREPARED BY:
OLIVER R. MARIANO, ASEAN Eng
DESIGNER
REG. NO.: 0000109 PTR NO.: 6350075
TIN NO.: 185-452-561 ISSUED ON: 01/05/2021
ISSUED AT: BULACAN

SUBMITTED BY:
AR. MA. SATURNINA C. PARUNGAO, fuap
DEPUTY DIRECTOR, PROJECT MANAGEMENT OFFICE
CAD BY: HJC CHECK BY: ORM
DATE: DATE:

RECOMMENDING APPROVAL:
ENGR. IVY MAR J. RAMOS
EXECUTIVE DIRECTOR, STRATEGIC MANAGEMENT
AND DEVELOPMENT







 



 
RECOMMENDING APPROVAL:
TEODY C. SAN ANDRES, Ph.D
EXECUTIVE VICE PRESIDENT


APPROVAL:
CECILIA N. GASCON, Ph.D
UNIVERSITY PRESIDENT

SHEET CONTENTS:
AVR 1 & 2 5TH FLOOR.


SHEET NO:
AUX-4
07

LEGEND:



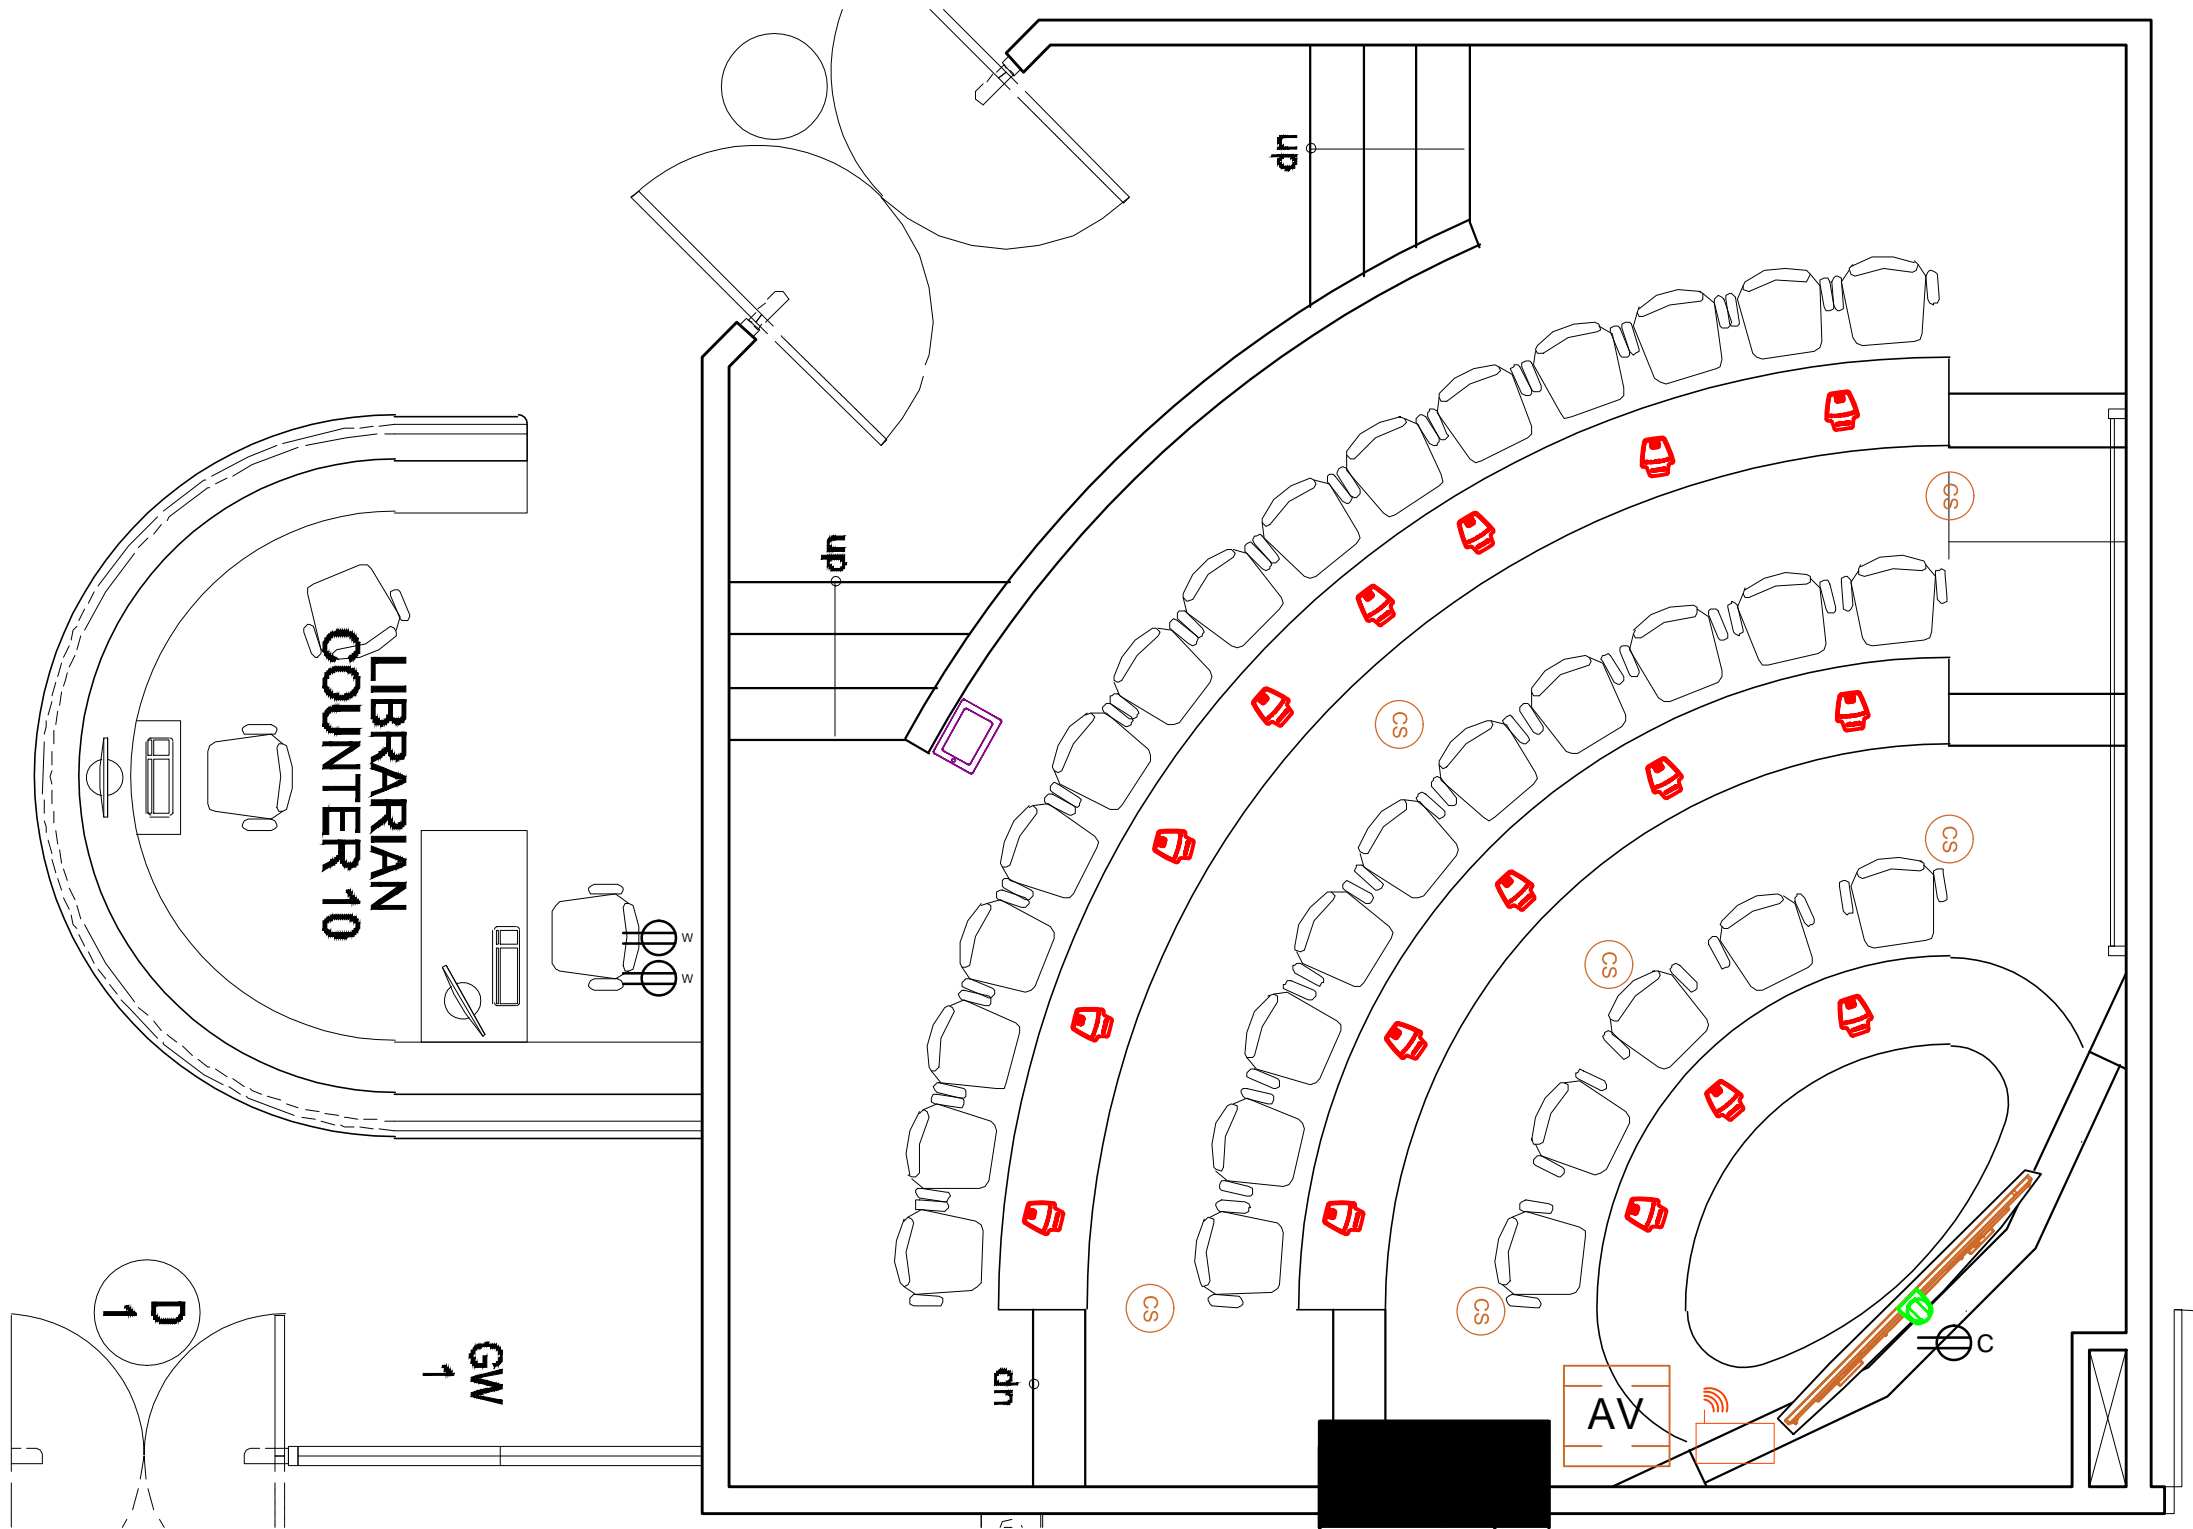

















AUDIO	
	6.5" CEILING SPEAKER
	BOUNDARY MIC
VIDEO	
	84"LED SCREEN
	BYOD
	PTZ CAMERA
CONTROL/AV PATCH	
	TOUCH PANEL - TABLE MOUNT
	AUDIO-VIDEO PATCH PLATE
AV RACK	
	AUDIO-VIDEO EQUIPMENT RACK
ELECTRICAL	
	FLOOR - POP UP BOX
	CEILING MOUNT
	WALL MOUNT




TELECONFERENCING ROOM (5TH FLR.)
SOUND SYSTEM / SPECIAL LIGHTING & POWER LAYOUT
SCALE: NTS


 BULACAN STATE UNIVERSITY PROJECT MANAGEMENT OFFICE BRGY. GUINHAWA, CITY OF MALOLOS, BULACAN Tel. No.: (044) 919-7800 E-mail address: bulsu.pmo2013@gmail.com	PROJECT TITLE:	PREPARED BY:	SUBMITTED BY:	RECOMMENDING APPROVAL:	RECOMMENDING APPROVAL:	APPROVAL:	SHEET CONTENTS:	SHEET NO:
	DATA NETWORK - STRUCTURED CABLING AND COMPONENTS AND SOUND SYSTEM OF E-LIBRARY BUILDING	OLIVER R. MARIANO, ASEAN Eng DESIGNER	AR. MA. SATURNINA C. PARUNGAO, fuap DEPUTY DIRECTOR, PROJECT MANAGEMENT OFFICE	ENGR. IVY MAR J. RAMOS EXECUTIVE DIRECTOR, STRATEGIC MANAGEMENT AND DEVELOPMENT	TEODY C. SAN ANDRES, Ph.D EXECUTIVE VICE PRESIDENT	CECILIA N. GASCON, Ph.D UNIVERSITY PRESIDENT	TELECONFERENCING RM, 5TH FLR.	AUX-5
	REG. NO.: 0000109	PTR NO.: 6350075	CAD BY:	CHECK BY:				07
	TIN NO.: 185-452-561	ISSUED ON: 01/05/2021	HJC	ORM				
	ISSUED AT: BULACAN		DATE:	DATE:				
LOCATION: BULSU MALOLOS.								

LEGEND:



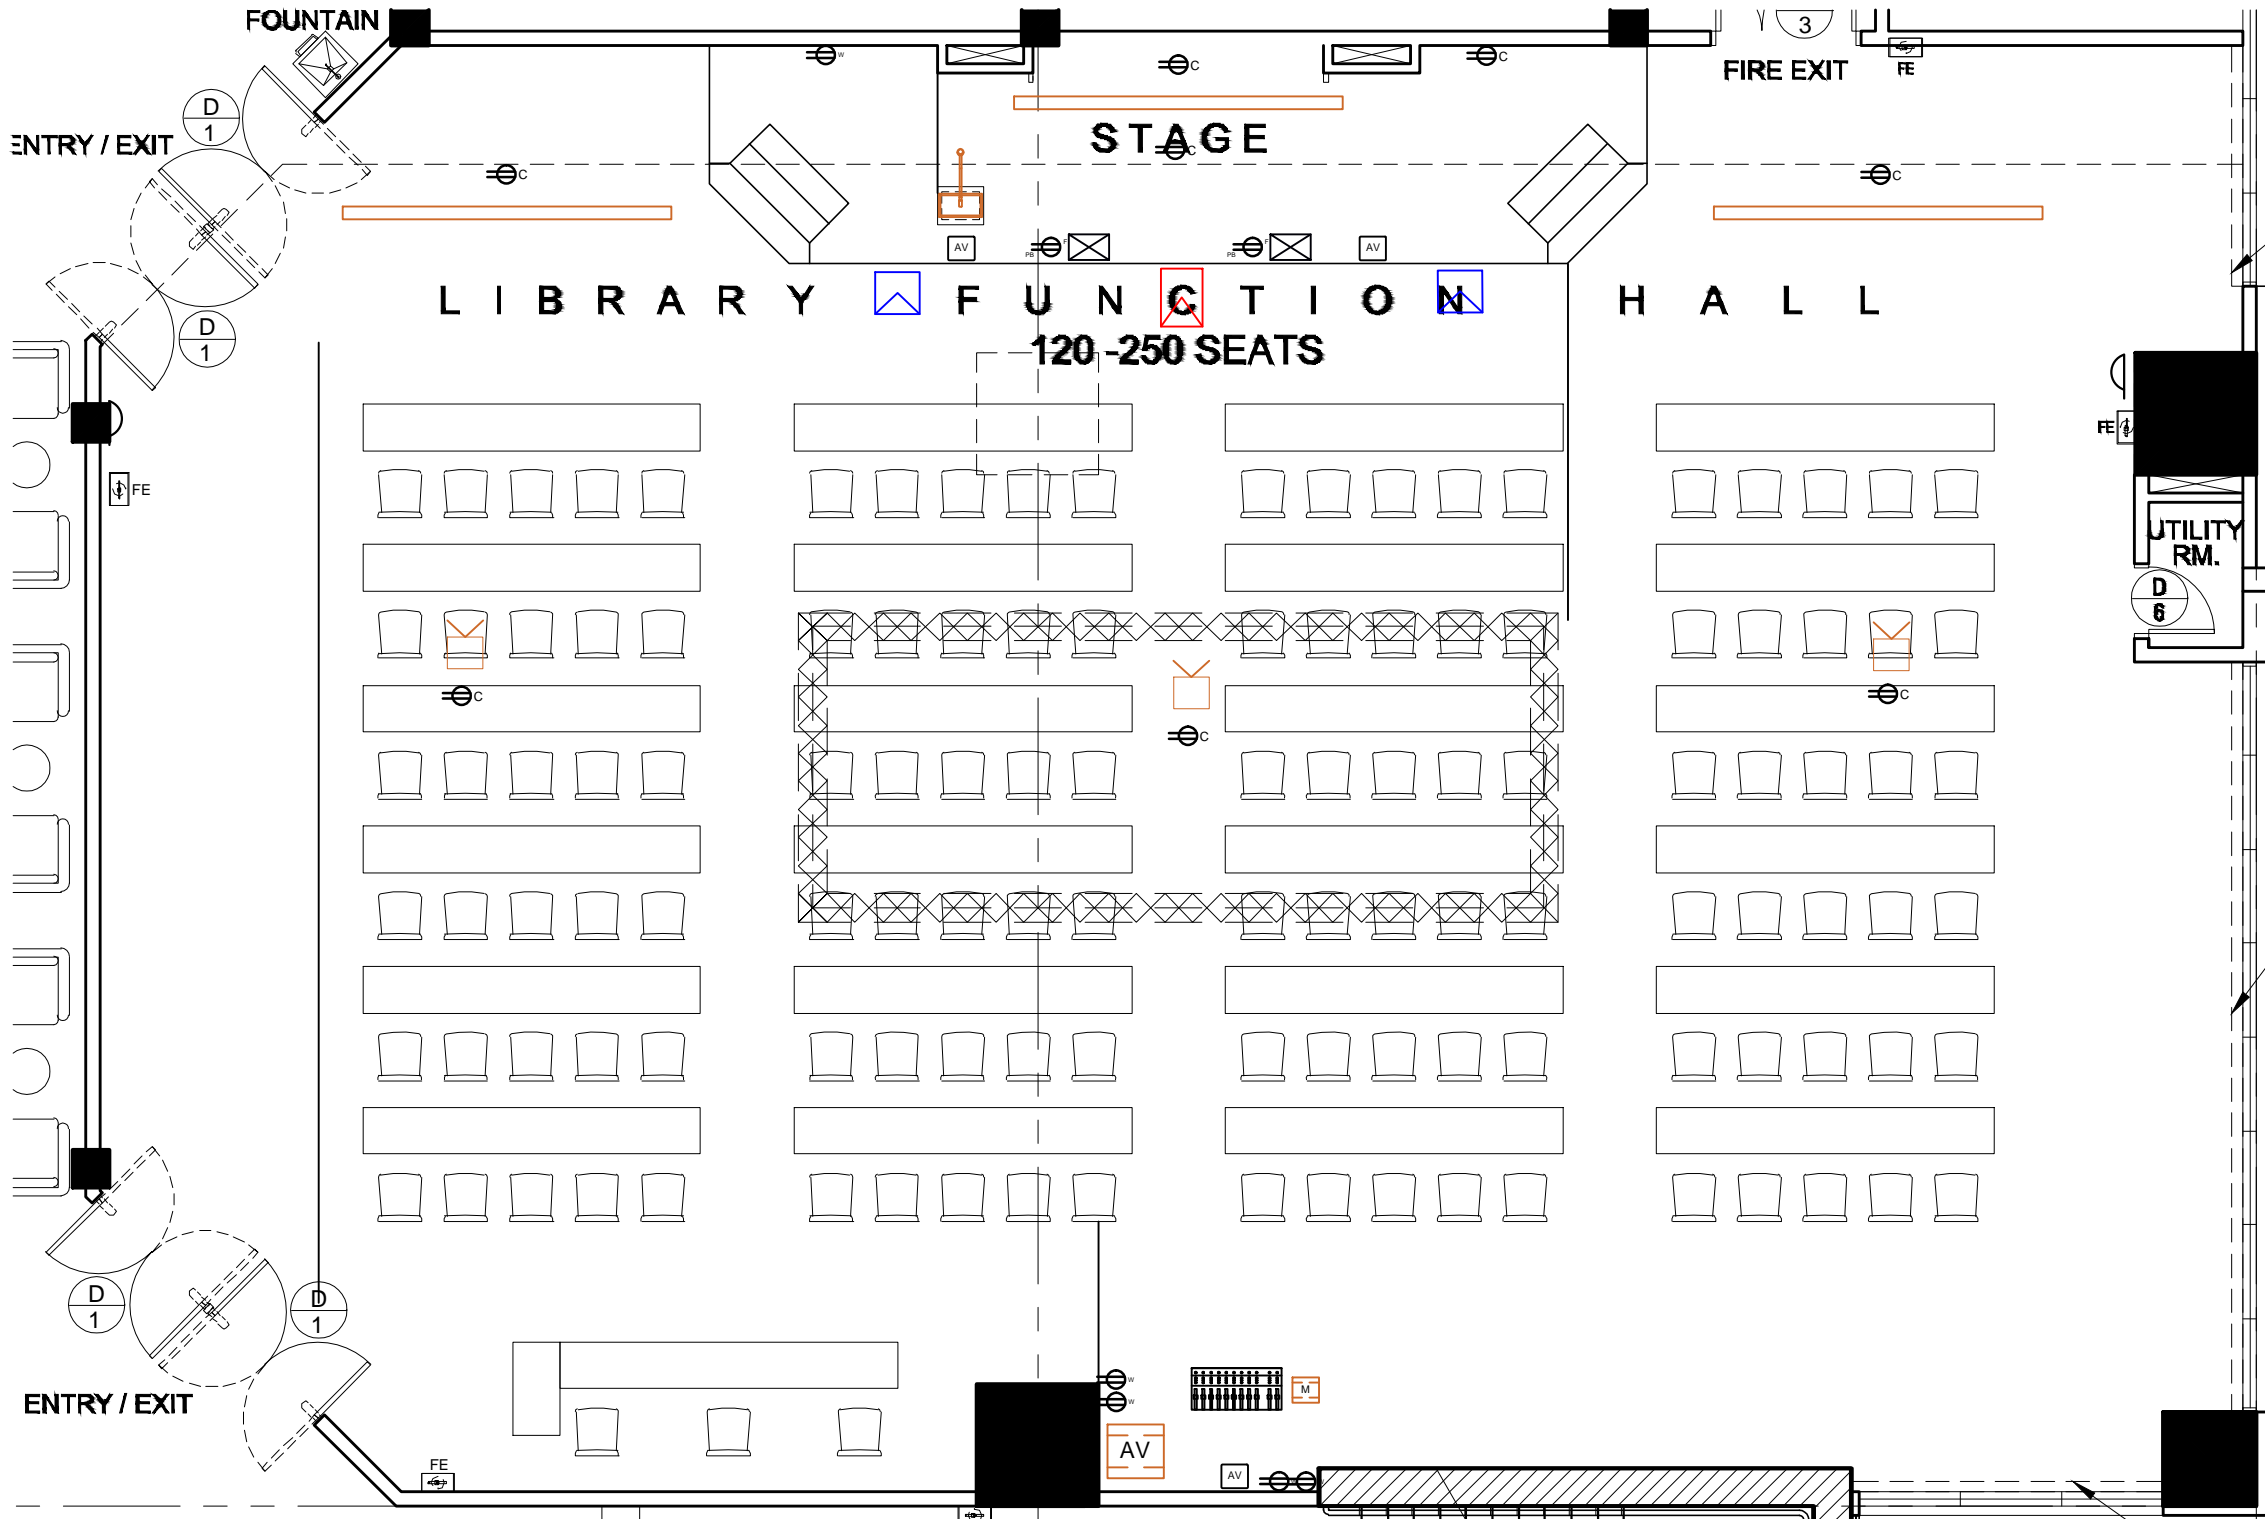


 











 

 
AUDIO	
	FOH - MAIN CLUSTER
	FOH - MAIN SOBWOOFER
	STAGE MONITOR
	DIGITAL CONSOLE
	STAGE BOX
	ANTENNA SYSTEM
	PORTABLE RACK FOR MIC
	PODIUM W/MIC
	WIRELESS MIC
VIDEO	
	MOTORIZED SCREEN 150"
	LASER 3LCD PROJECTOR
LIGHTING	
	LED PAR WARM/COOL WHITE
	LED PAR RGBW
	LED WASH RGBW
	LIGHTING BATTEN
CONTROL/AV PATCH	
	KEYPAD - VIDEO
AV RACK	
	AUDIO-VIDEO EQUIPMENT RACK
ELECTRICAL	
	FLOOR - POP UP BOX
	CEILING MOUNT
	WALL MOUNT




LIBRARY FUNCTION HALL (7TH FLR.)
SOUND SYSTEM / SPECIAL LIGHTING & POWER LAYOUT
SCALE: NTS

 BULACAN STATE UNIVERSITY PROJECT MANAGEMENT OFFICE BRGY. GUINHAWA, CITY OF MALOLOS, BULACAN Tel. No.: (044) 919-7800 E-mail address: bulsu.pmo2013@gmail.com	PROJECT TITLE: DATA NETWORK - STRUCTURED CABLING AND COMPONENTS AND SOUND SYSTEM OF E-LIBRARY BUILDING LOCATION: BULSU MALOLOS.	PREPARED BY: OLIVER R. MARIANO, ASEAN Eng DESIGNER REG. NO.: 0000109 PTR NO.: 6350075 TIN NO.: 185-452-561 ISSUED ON: 01/05/2021 ISSUED AT: BULACAN	SUBMITTED BY: AR. MA. SATURNINA C. PARUNGAO, fuap DEPUTY DIRECTOR, PROJECT MANAGEMENT OFFICE CAD BY: HJC CHECK BY: ORM DATE: DATE:	RECOMMENDING APPROVAL: ENGR. IVY MAR J. RAMOS EXECUTIVE DIRECTOR, STRATEGIC MANAGEMENT AND DEVELOPMENT	RECOMMENDING APPROVAL: TEODY C. SAN ANDRES, Ph.D EXECUTIVE VICE PRESIDENT	APPROVAL: CECILIA N. GASCON, Ph.D UNIVERSITY PRESIDENT	SHEET CONTENTS: LIBRARY FUNCTION HALL 7TH FLR.	SHEET NO: AUX-6 07

LEGEND:

AUDIO	
	FOH - MAIN CLUSTER
	FOH - MAIN SOBWOOFER
	STAGE MONITOR
	DIGITAL CONSOLE
	STAGE BOX
	ANTENNA SYSTEM
	PORTABLE RACK FOR MIC
	PODIUM W/MIC
	WIRELESS MIC
VIDEO	
	MOTORIZED SCREEN 150"
	LASER 3LCD PROJECTOR
LIGHTING	
	LED PAR WARM/COOL WHITE
	LED PAR RGBW
	LED WASH RGBW
	LIGHTING BATTEN
CONTROL/AV PATCH	
	KEYPAD - VIDEO
AV RACK	
	AUDIO-VIDEO EQUIPMENT RACK
ELECTRICAL	
	FLOOR - POP UP BOX
	CEILING MOUNT
	WALL MOUNT

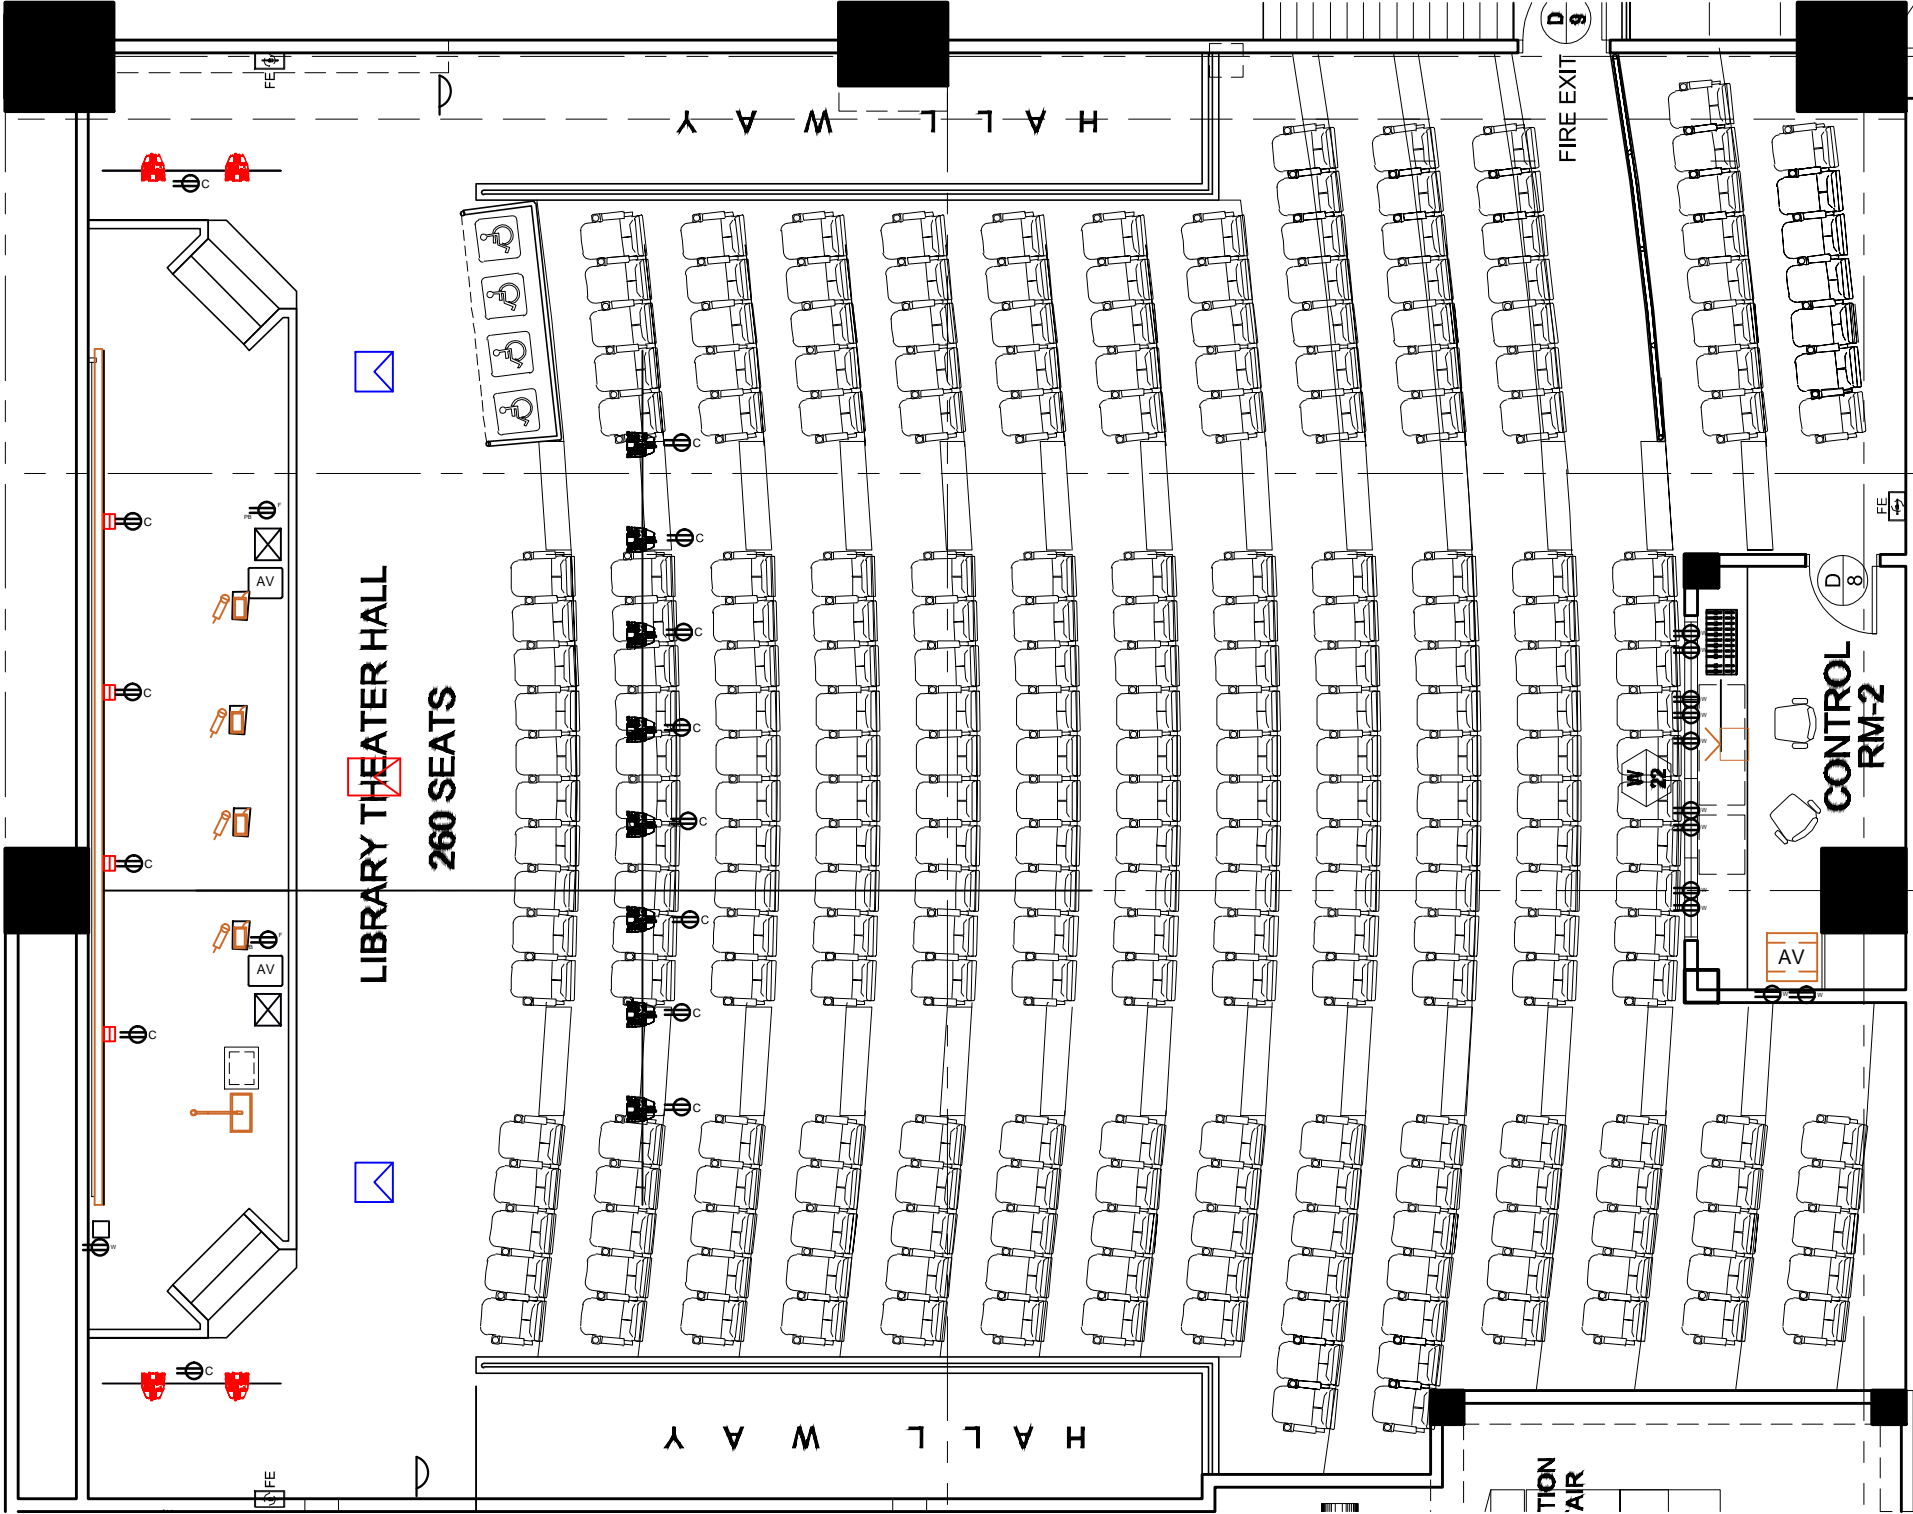

LIBRARY THEATER HALL (7TH FLR.)

SOUND SYSTEM / SPECIAL LIGHTING & POWER LAYOUT

SCALE:

NTS



BULACAN STATE UNIVERSITY
PROJECT MANAGEMENT OFFICE
BRGY. GUINHAWA, CITY OF MALOLOS, BULACAN
Tel. No.: (044) 919-7800
E-mail address: bulsu.pmo2013@gmail.com

PROJECT TITLE:
DATA NETWORK - STRUCTURED
CABLING AND COMPONENTS
AND SOUND SYSTEM OF
E-LIBRARY BUILDING
LOCATION: BULSU MALOLOS.

PREPARED BY:
OLIVER R. MARIANO, ASEAN Eng
DESIGNER
REG. NO.: 0000109 PTR NO.: 6350075
TIN NO.: 185-452-561 ISSUED ON: 01/05/2021
ISSUED AT: BULACAN

SUBMITTED BY:
AR. MA. SATURNINA C. PARUNGAO, fuap
DEPUTY DIRECTOR, PROJECT MANAGEMENT OFFICE
CAD BY: HJC CHECK BY: ORM
DATE: DATE:

RECOMMENDING APPROVAL:
ENGR. IVY MAR J. RAMOS
EXECUTIVE DIRECTOR, STRATEGIC MANAGEMENT
AND DEVELOPMENT

RECOMMENDING APPROVAL:
TEODY C. SAN ANDRES, Ph.D
EXECUTIVE VICE PRESIDENT

APPROVAL:
CECILIA N. GASCON, Ph.D
UNIVERSITY PRESIDENT

SHEET CONTENTS:
LIBRARY THEATER HALL 7TH FLR.

SHEET NO:
AUX-7
07