



Republic of the Philippines
BULACAN STATE UNIVERSITY
City of Malolos

BIDS AND AWARDS COMMITTEE FOR GOODS, SUPPLIES, AND SERVICES

February 11, 2023

Bid Bulletin No. 4 **Modifications in the Terms of Reference and** **Plans/Drawings**

This Bid Bulletin no. 4 is issued to modify or amend items in the Bidding Documents for project: **“Supply, delivery and installation of Intelligent Video Surveillance System for Bulacan State University Main and External Campuses (G-2022-33)”**. This shall form an integral part of the said Bidding Documents.

I. TERMS OF REFERENCE

FROM					TO				
Distribution of Camera per Campus					Distribution of Camera per Campus				
Campus	Bullet type	Dome Type	PTZ Type	Total:	Campus	Bullet type	Dome Type	PTZ Type	Total:
Bustos	5	24	-	29	Bustos	10	19	-	29
					<i>Please see attached Plans/Drawings for Bustos Campus</i>				


Note:

- Item, description or specifications not mentioned above are without modifications and will remain as it is in the bidding documents
- Modified/additional entries are underlined, bold and italicized.


This Supplemental/ Bid Bulletin no. 4 is issued this **11th** day of February, 2023 for guidance and information of all concerned.

Dr. DOLLY P. MAROMA

Chairperson, BAC for Goods, Supplies & Services

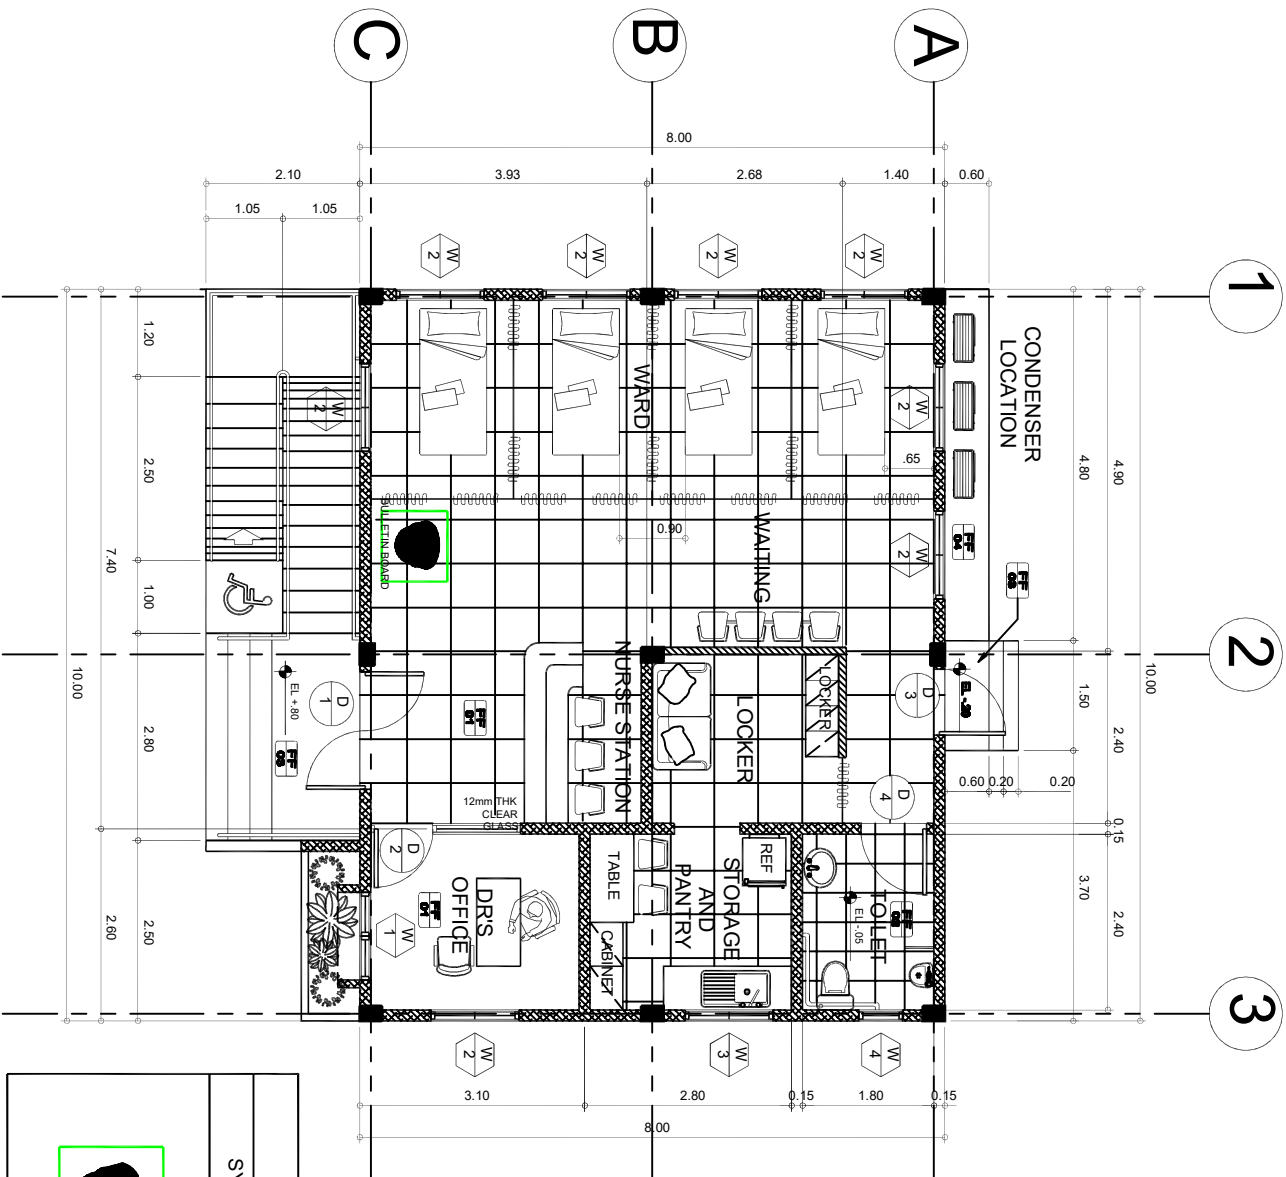


LEGEND	
SYMBOL	DESCRIPTION
	PROPOSED BULLET CCTV CAMERA

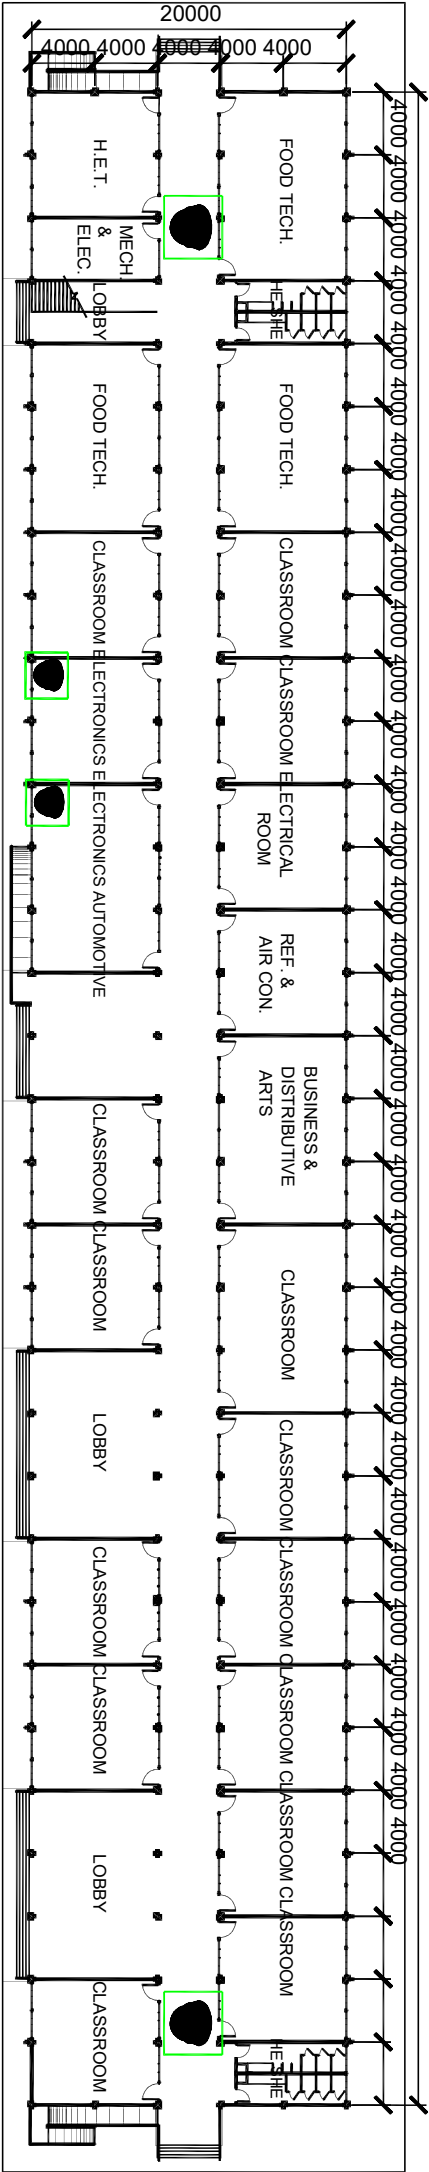

GROUND FLOOR PLAN


SCALE 1:400MM

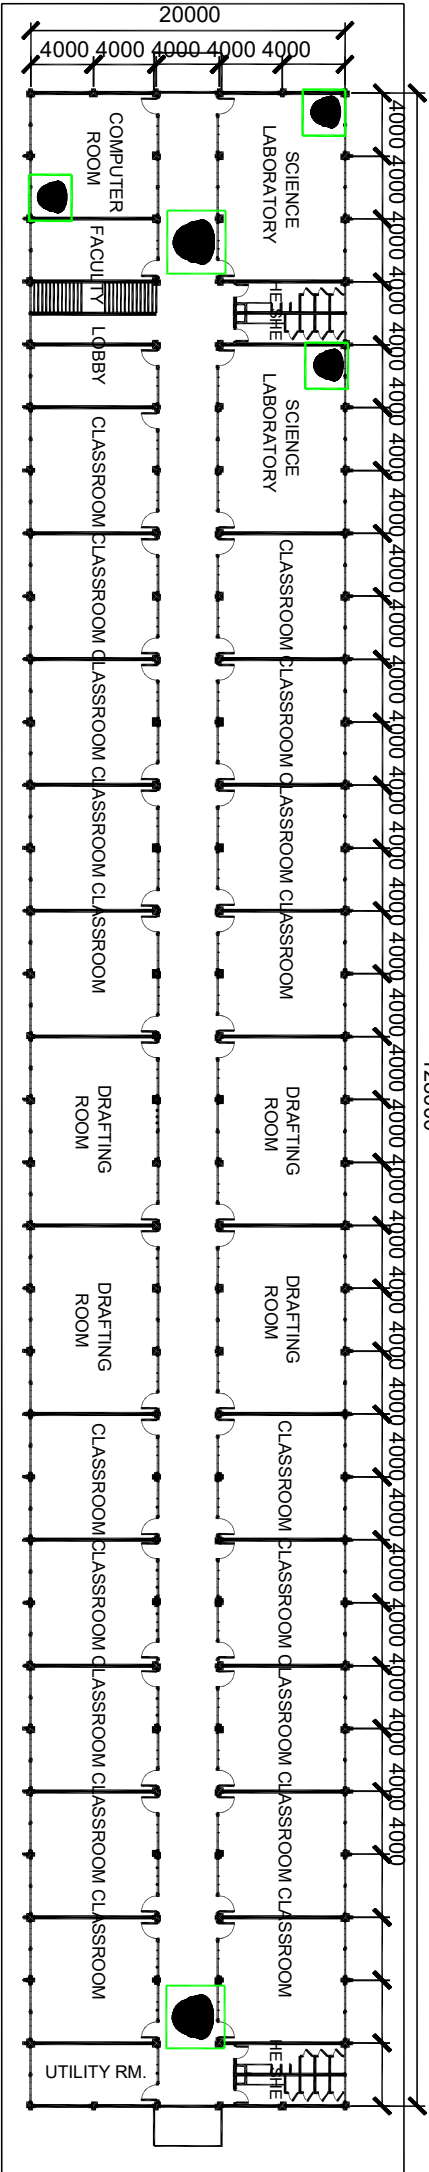

2ND FLOOR PLAN

SCALE 1:400MM

LEGEND	
SYMBOL	DESCRIPTION
	PROPOSED BULLET CCTV CAMERA

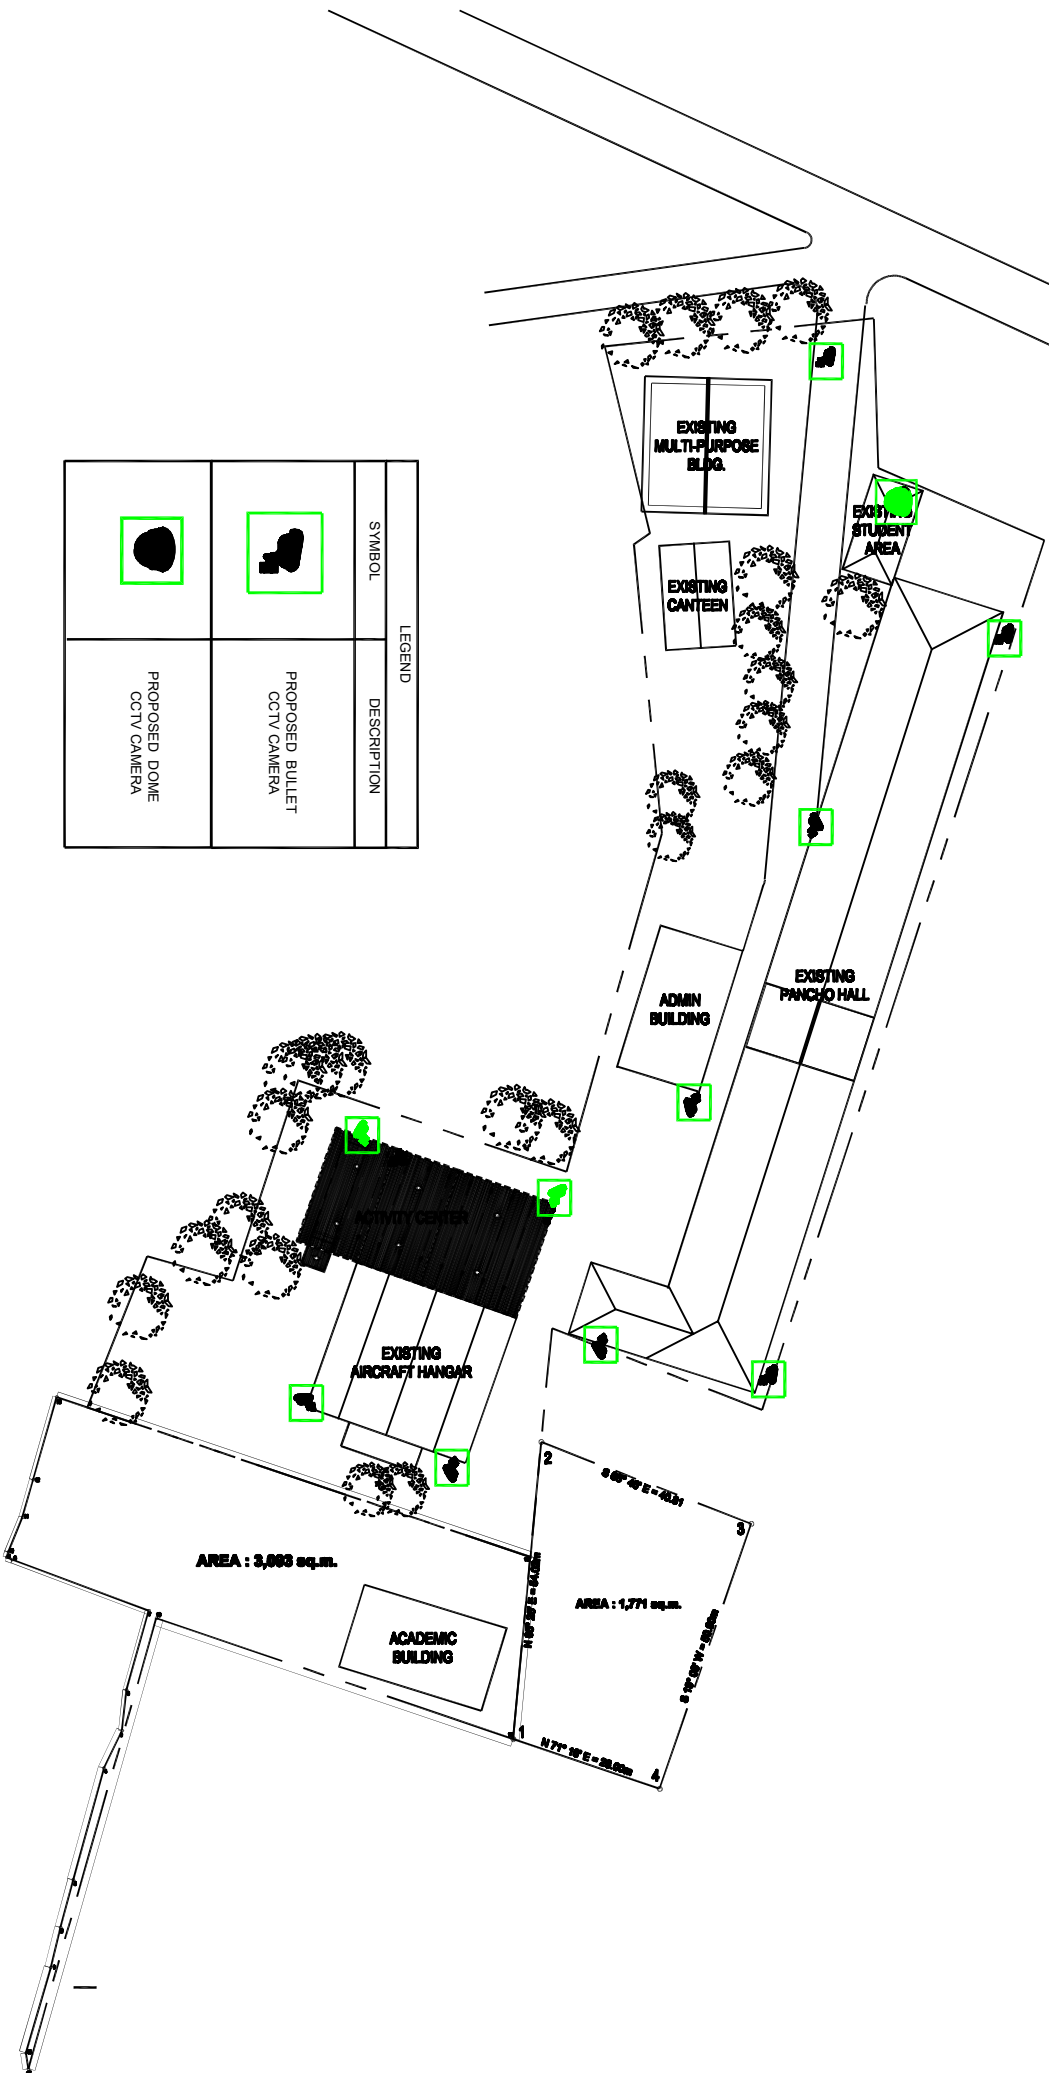

1

SITE DEVELOPMENT PLAN

A-1

SCALE:

NTS.

BULSU BUSTOS